



LEVEL 1

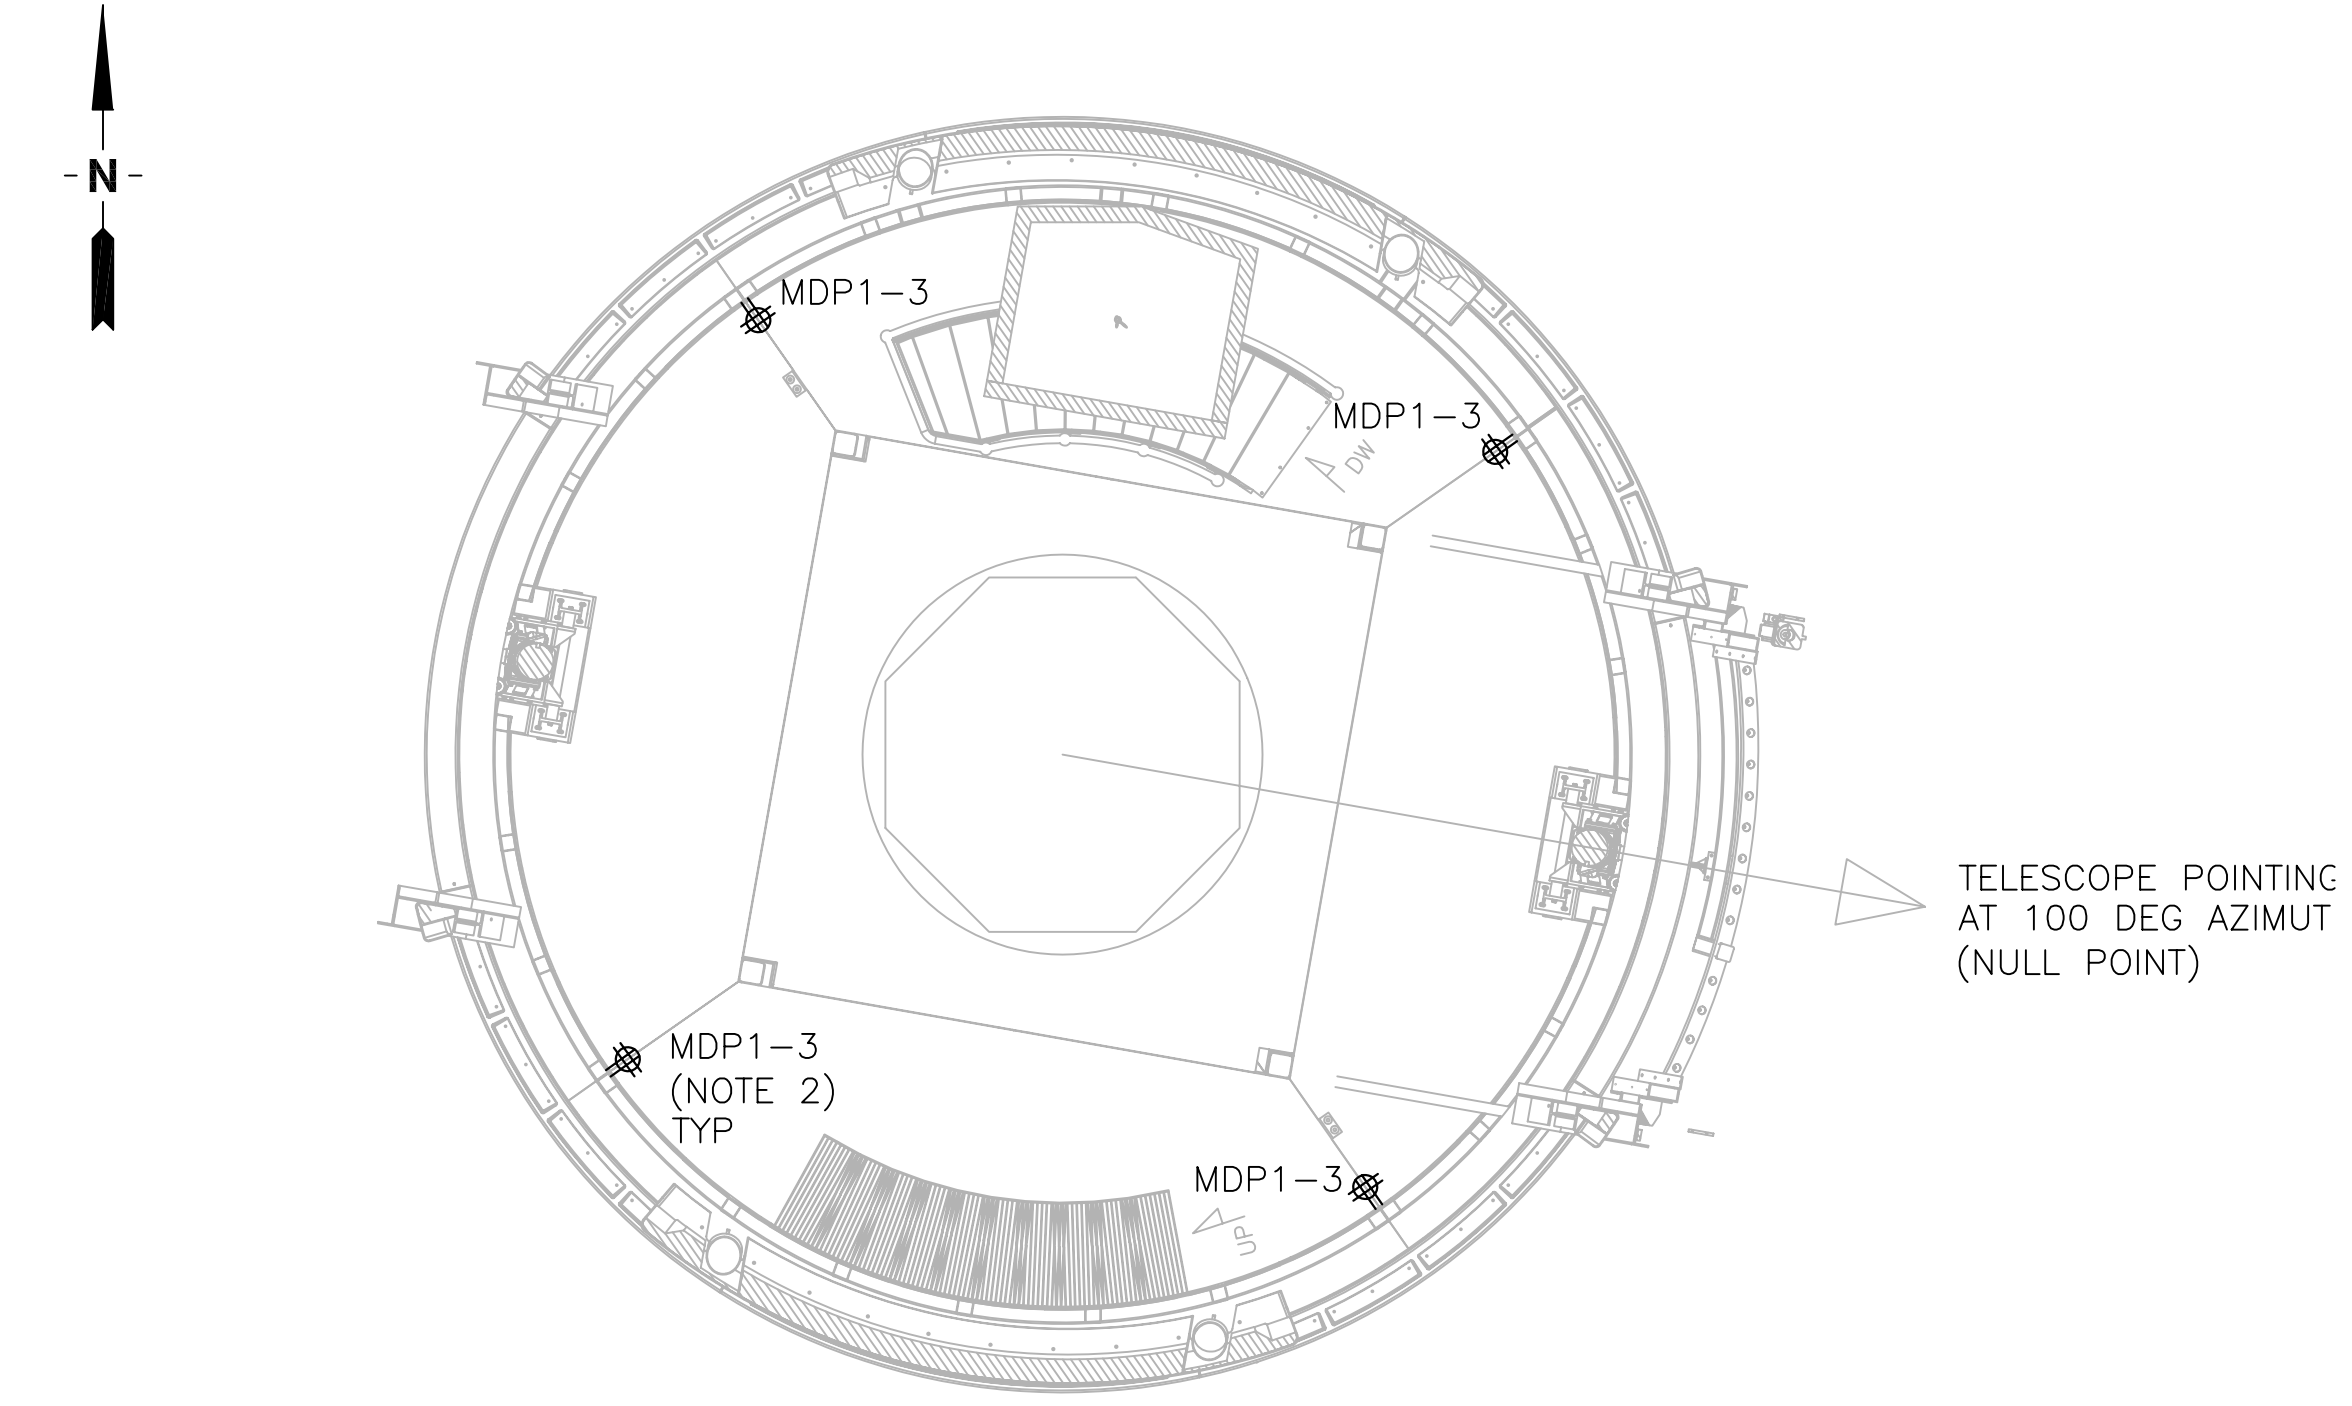

LEVEL 2

**NOTES:**

1. MOUNT ALL DUPLEX RECEPTACLES AT LEVEL 1, 18" ABOVE FINISH FLOOR.
2. MOUNT ALL QUAD RECEPTACLES AT LEVEL 2, 48" ABOVE FINISH FLOOR.

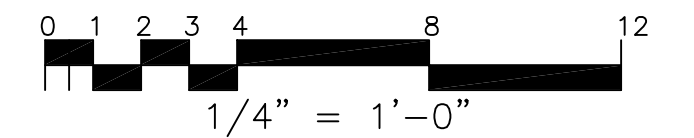

2101 Webster St., Suite 1000  
 Oakland, CA 94612  
 Phone: (510)419-6000  
 Fax : (510)419-5355

**UNIVERSITY OF CALIFORNIA**  
 PHYSICAL PLANNING AND CONSTRUCTION  
 SANTA CRUZ CAMPUS SANTA CRUZ, CALIFORNIA

DESIGNED  
 DRAWN  
 CHECKED

APPROVED

LOCATION

SHEET TITLE  
**APF LEVEL 1 & LEVEL 2 POWER PLAN**  
 MOUNT HAMILTON UCO/LICK  
 AUTOMATED PLANET FINDER SITE WORK  
 BUILDING OR PROJECT

FILE NO.  
 6639  
 DATE  
 02/03/05

SHEET  
**E5**  
 OF