


- NOTES:**
- DRAIN PIPE SHALL BE COPPER PIPE GR. K. W./BRAZING JOINTS.
 - LOCATE PIPE SUPPORT TO CLEAR BUILDING WINDOWS, PROVIDE ADDITIONAL SUPPORTS AS NEEDED TO LIMIT PIPE SAGGING TO LESS THAN 1/8".
 - LOCATION OF PIPING CONNECTIONS TO CHILLER & PUMP MODULES SHALL BE PER CERTIFIED VENDOR DRAWINGS.

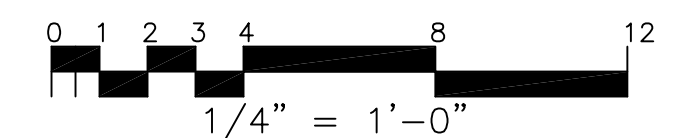

<p>EarthTech A Tyco International Ltd. Company</p>	2101 Webster St., Suite 1000 Oakland, CA 94612 Phone: (510)419-6000 Fax: (510)419-5355		UNIVERSITY OF CALIFORNIA PHYSICAL PLANNING AND CONSTRUCTION SANTA CRUZ CAMPUS SANTA CRUZ, CALIFORNIA		DESIGNED _____ DRAWN _____ CHECKED _____	APPROVED _____	LOCATION _____ SCALE AS SHOWN	SHEET TITLE CHILLED GLYCOL PIPING PLAN MOUNT HAMILTON UCO/LICK AUTOMATED PLANET FINDER SITE WORK BUILDING OR PROJECT	FILE NO. 6639 DATE 02/14/05	SHEET M1 OF _____
---	---	--	--	--	--	----------------	----------------------------------	---	--------------------------------------	--------------------------------