


# MOUNT HAMILTON UCO/LICK AUTOMATED PLANET FINDER SITE WORK

UNIVERSITY OF CALIFORNIA SANTA CRUZ

## LOCATION MAP

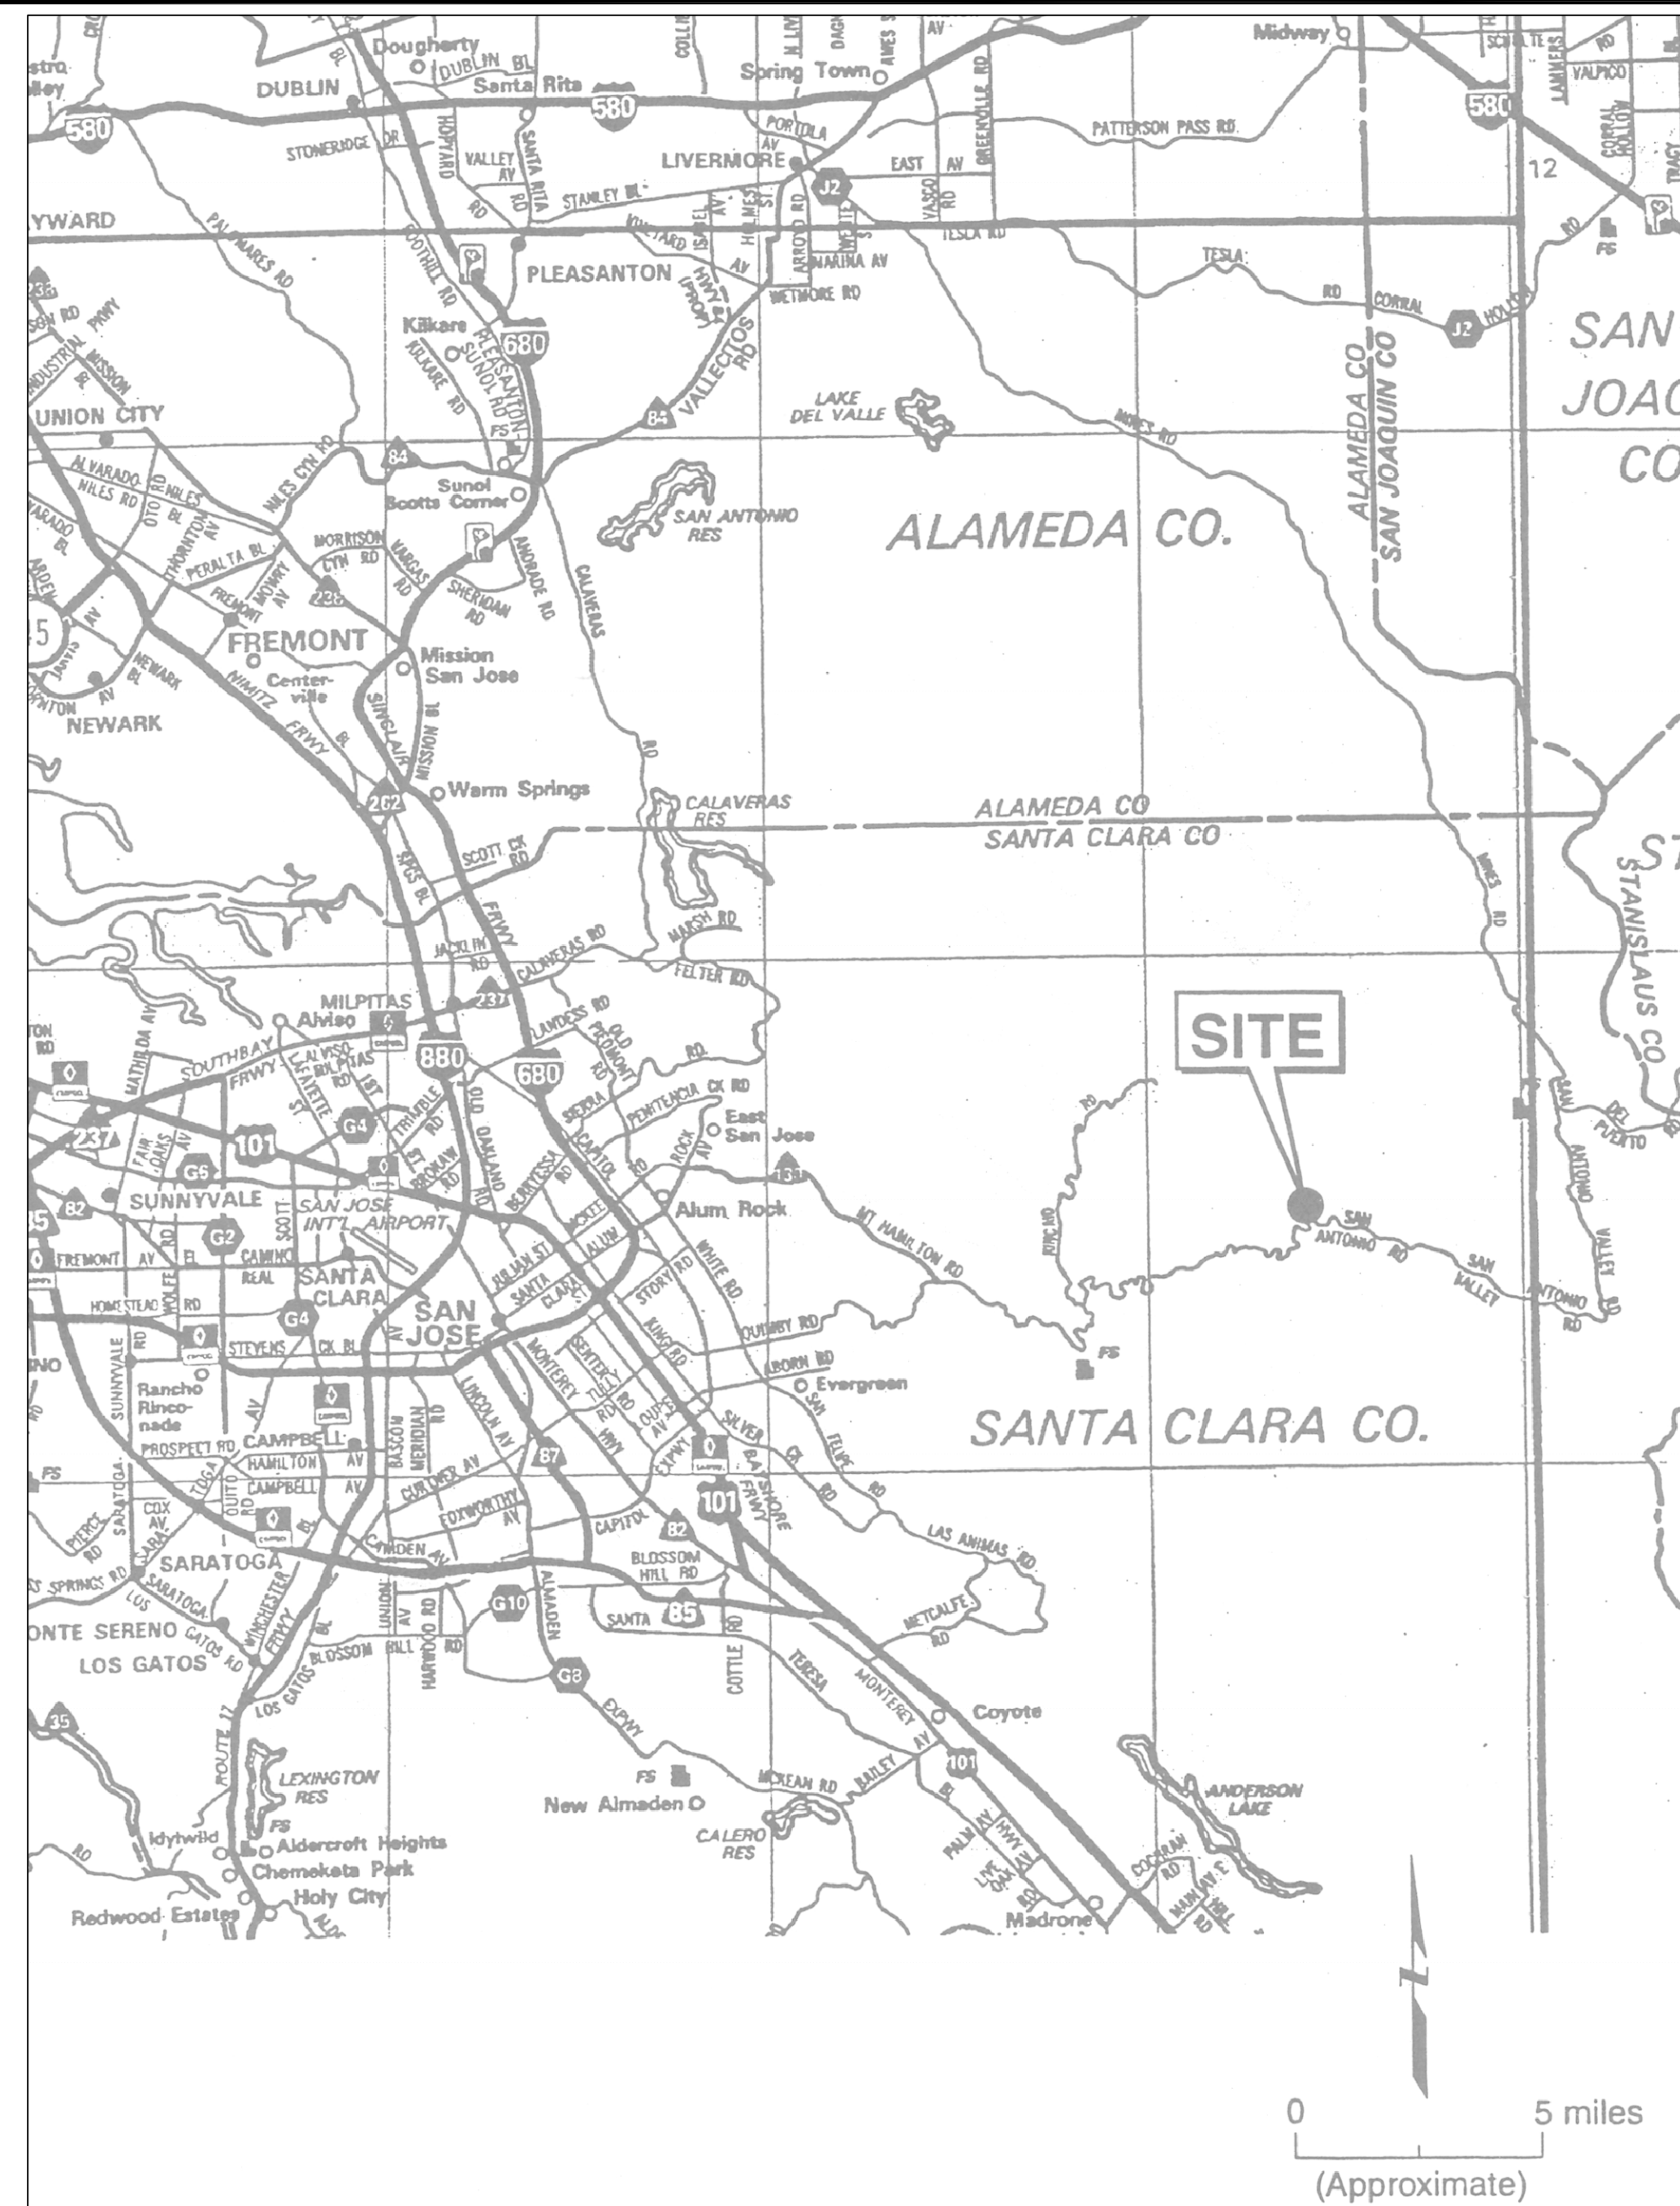

## VICINITY MAP

VICINITY MAP TO FOLLOW

## SHEET INDEX

SHEET NUMBER	DESCRIPTION
T1	TITLE SHEET
<b>CIVIL</b>	
C1	SITE PLAN
C2	GRADING PLAN & SECTIONS
C3	SECTIONS & DETAILS
<b>STRUCTURAL</b>	
S1	STRUCTURAL ABBREVIATIONS, GENERAL NOTES & REQUIREMENTS
S2	FOUNDATION & FLOOR PLAN
S3	SECTIONS
S4	CONCRETE DETAILS
S5	PIER CAP ASSEMBLY
<b>MECHANICAL</b>	
M1	CHILLED GLYCOL PIPING PLAN
M2	PIPE SUPPORT DETAILS
M3	SUPPORT DETAILS & SECTIONS
<b>ELECTRICAL</b>	
E1	SINGLE LINE DIAGRAM
E2	PANEL SCHEDULES
E3	CHILLER GLYCOL UNDERGROUND POWER PLAN
E4	APF SITE POWER PLAN
E5	APF LEVEL 1 & LEVEL 2 POWER PLAN
E6	APF LEVEL 3 POWER PLAN
E7	APF LEVEL 1 & LEVEL 2 LIGHTING PLAN
E8	APF LEVEL 3 LIGHTING PLAN
E9	GROUNDING PLAN
E10	LIGHTING SCHEDULE AND DETAILS
E11	GROUNDING & LIGHTNING PROTECTION DETAILS
E12	FIRE ALARM AND TEL/DATACOM RISER DIAGRAM